

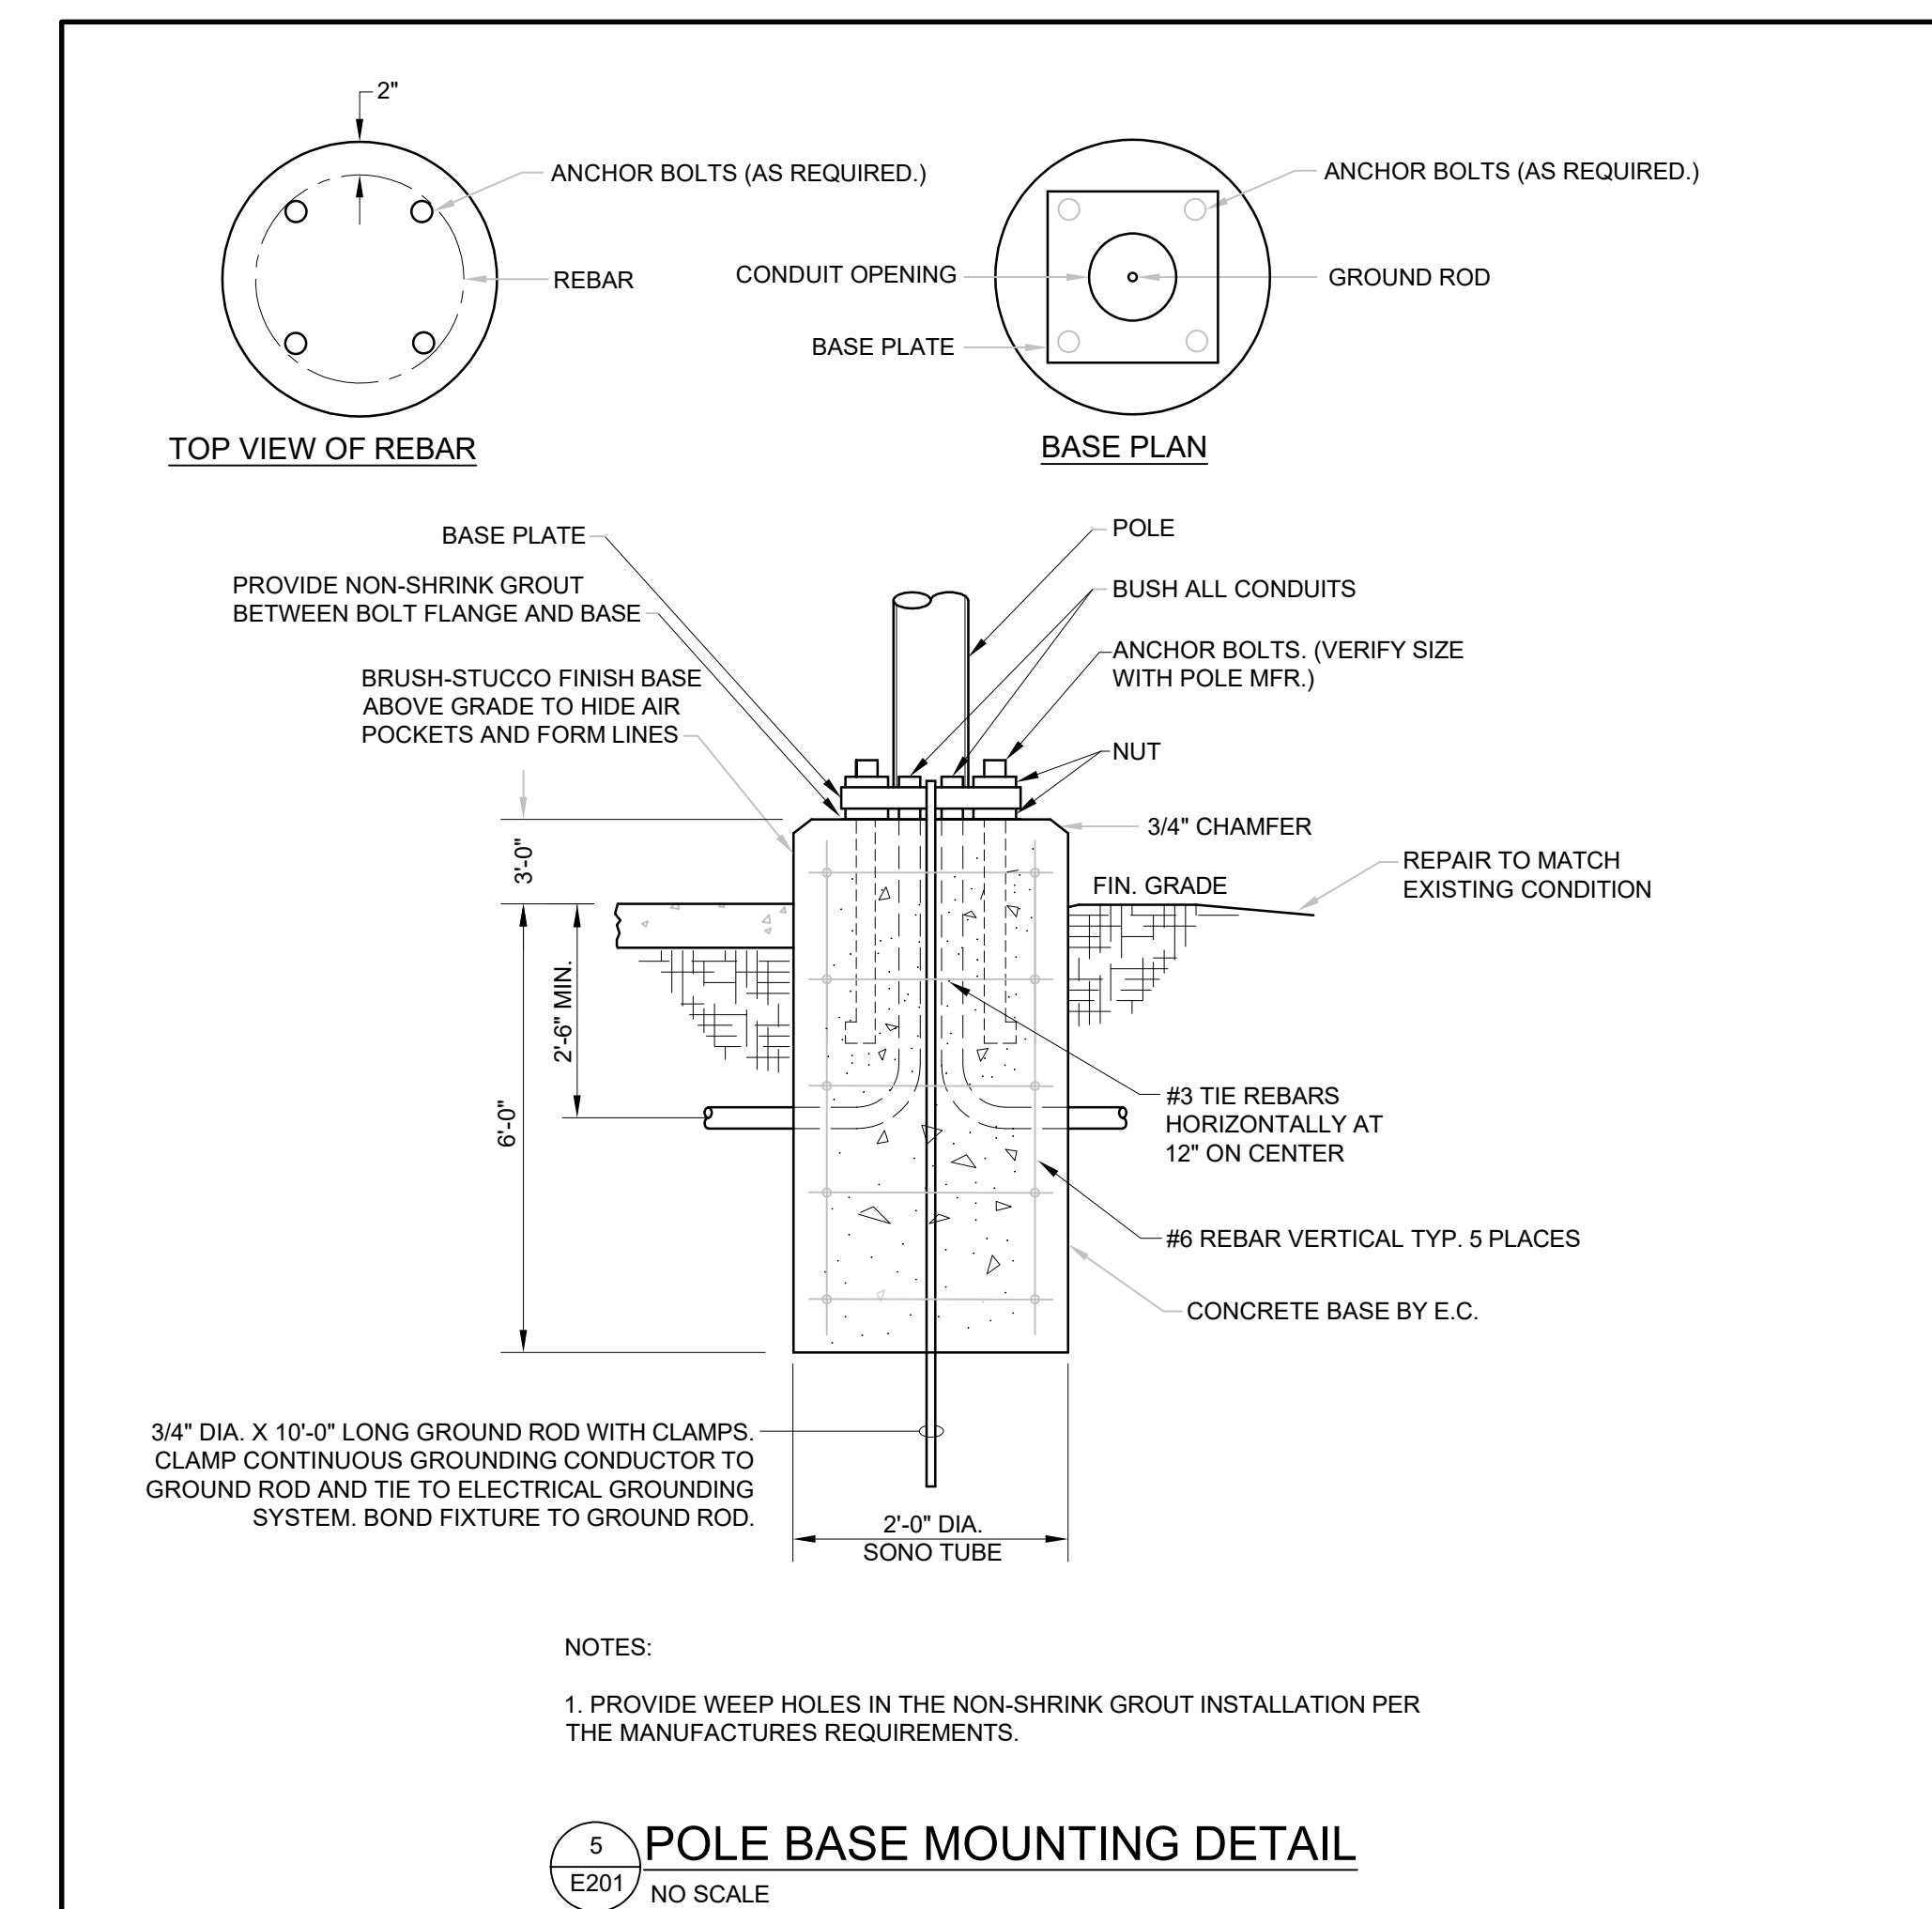
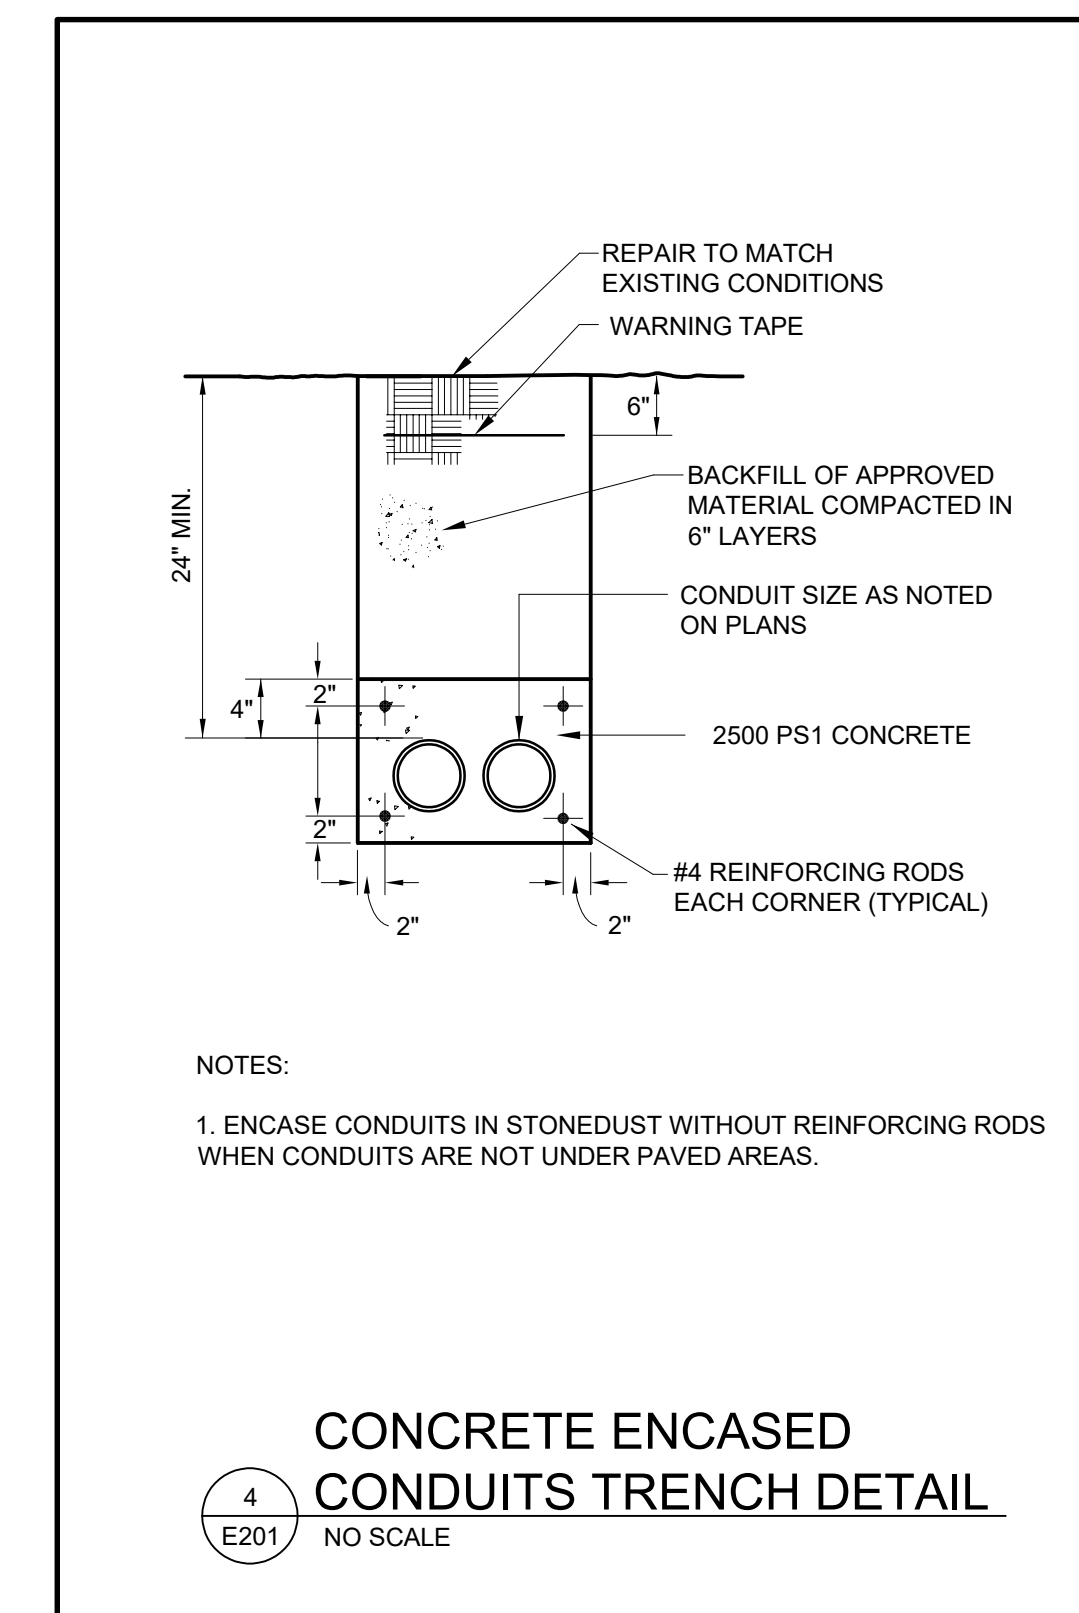
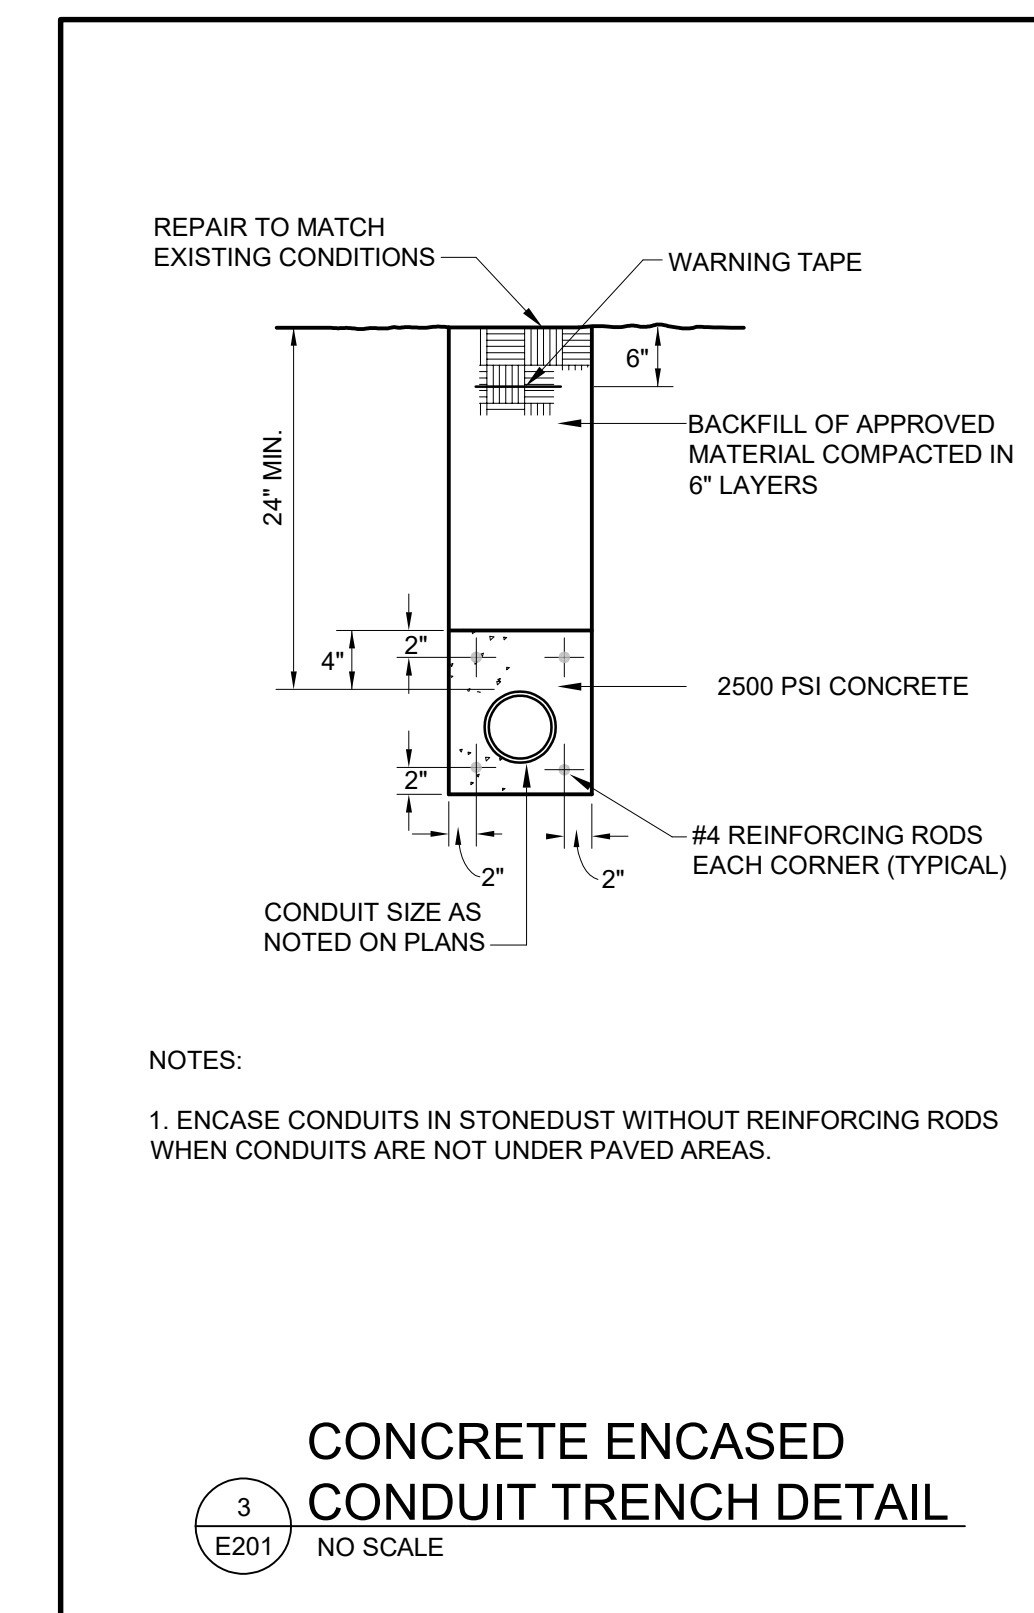
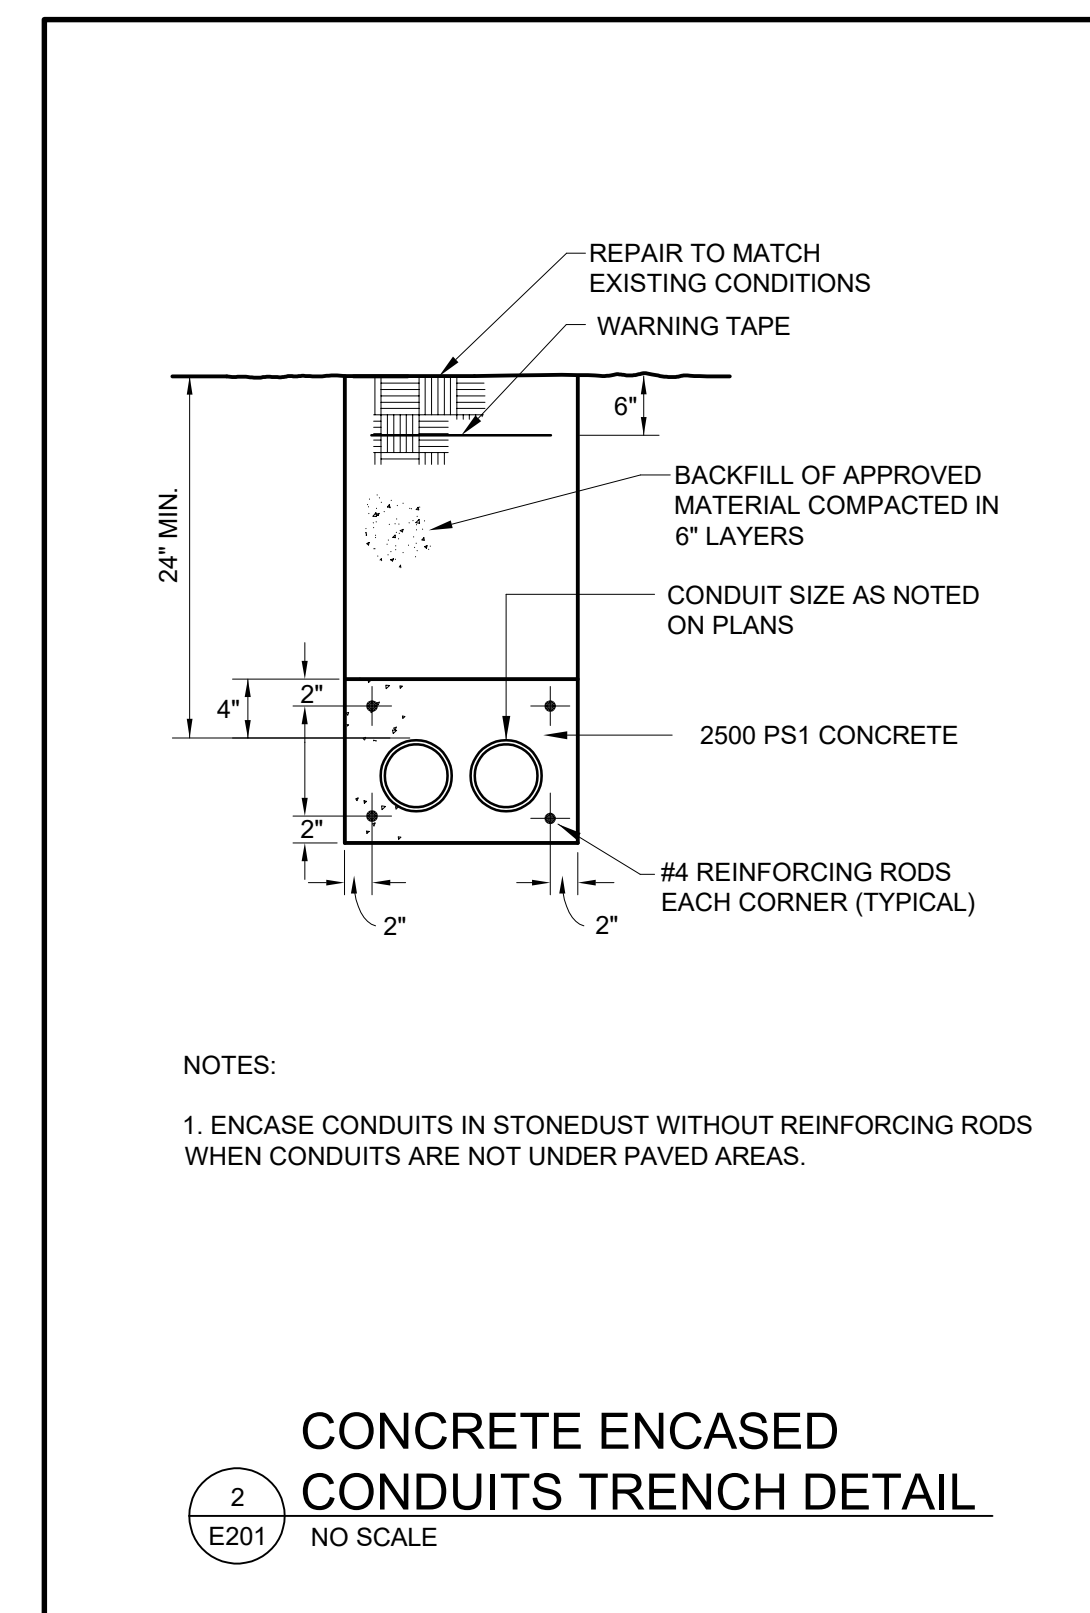
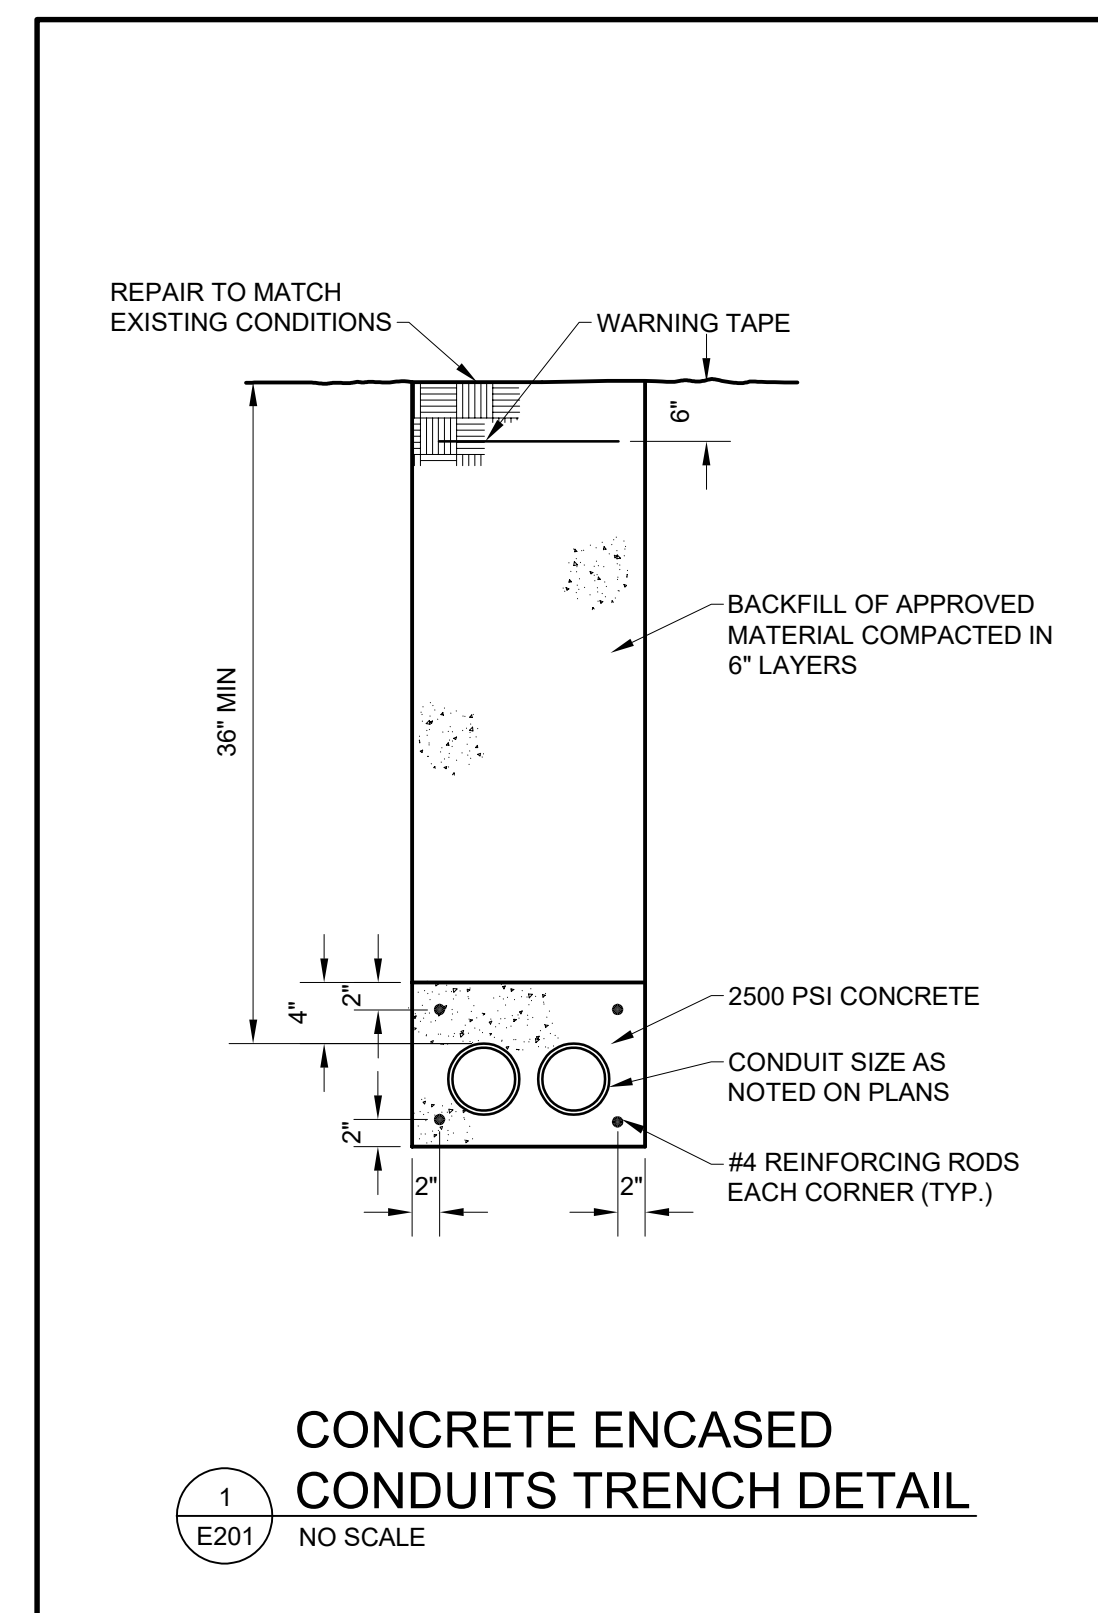


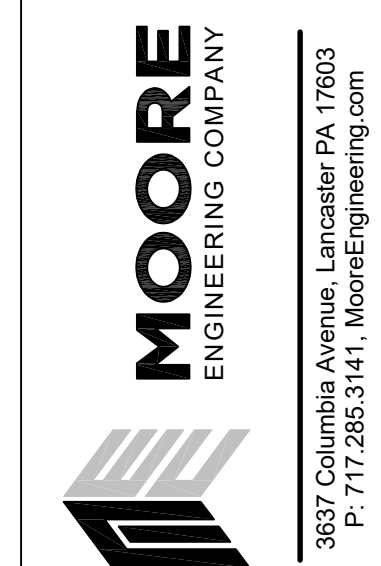

THIS DRAWING IS AN INSTRUMENT OF SERVICE, IS PROPERTY OF THE ARCHITECT, AND MAY NOT BE REPRODUCED WITHOUT HIS PERMISSION AND UNLESS THE REPRODUCTION COPIES ARE AS ARCHITECT DUE TO DISTORTION FROM REPRODUCTION PROCEDURES. DIMENSIONS SHALL NOT BE SCALED FROM THE DRAWINGS. ONLY DIMENSIONS AS SHOWN ARE VALID. CONTRACTORS SHALL VERIFY ALL DIMENSIONS AND LOCATIONS ON SITE BEFORE PROCEEDING WITH THE WORK.

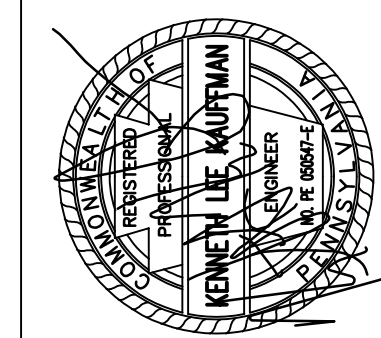

EAGLE BUILDING SOLUTIONS  
SITENWORK  
NORTH OAK STREET  
LITITZ, PA 17543

| NO.         | DATE | RELEASE |
|-------------|------|---------|
|             |      |         |
|             |      |         |
|             |      |         |
|             |      |         |
| Issue Date: |      | 02/02/2 |
| Drawn By:   |      | TPM     |
| Checked By: |      | TET     |

## ELECTRICAL DETAILS

Sheet Number:

E201

BH JOB NO. 23-015\_2301



